

From: [Bruce Harrison](#)
To: [Fire Prevention and Building and Safety Commission](#); [Boyle, Douglas J \(DHS\)](#); [Thompson, Crystal](#)
Subject: Modification of Building Use Public Health Emergewncy-COVID-19
Date: Tuesday, January 26, 2021 11:37:35 AM
Attachments: [2020-12-15 Joyce Center CRU Site Layout Map with Expanded Testing Capacity.pdf](#)

**** This is an EXTERNAL email. Exercise caution. DO NOT open attachments or click links from unknown senders or unexpected email. ****

Commission

Please accept our remodel on the current modification of building use submittal for The Joyce Athletic Convocation Center (North Fieldhouse) at the University of Notre Dame. The remodel of the floor plan will allow increased diagnostic and surveillance testing of our Students and University Community for Public Health Emergency-COVID-19
The extension of the modification of building use will be for the duration of the Spring Semester (Feb/3/2021 to May/23/2021)

As with prior applications this will not affect structural integrity, impede egress, or constitute a hazardous condition within the building.

If you have any questions or concerns please feel free to contact me


With Respect and Thanks

Bruce

--

Bruce Harrison
Notre Dame Fire Chief
Firehouse Number: 574-631-6200
Cell: 574-339-1314



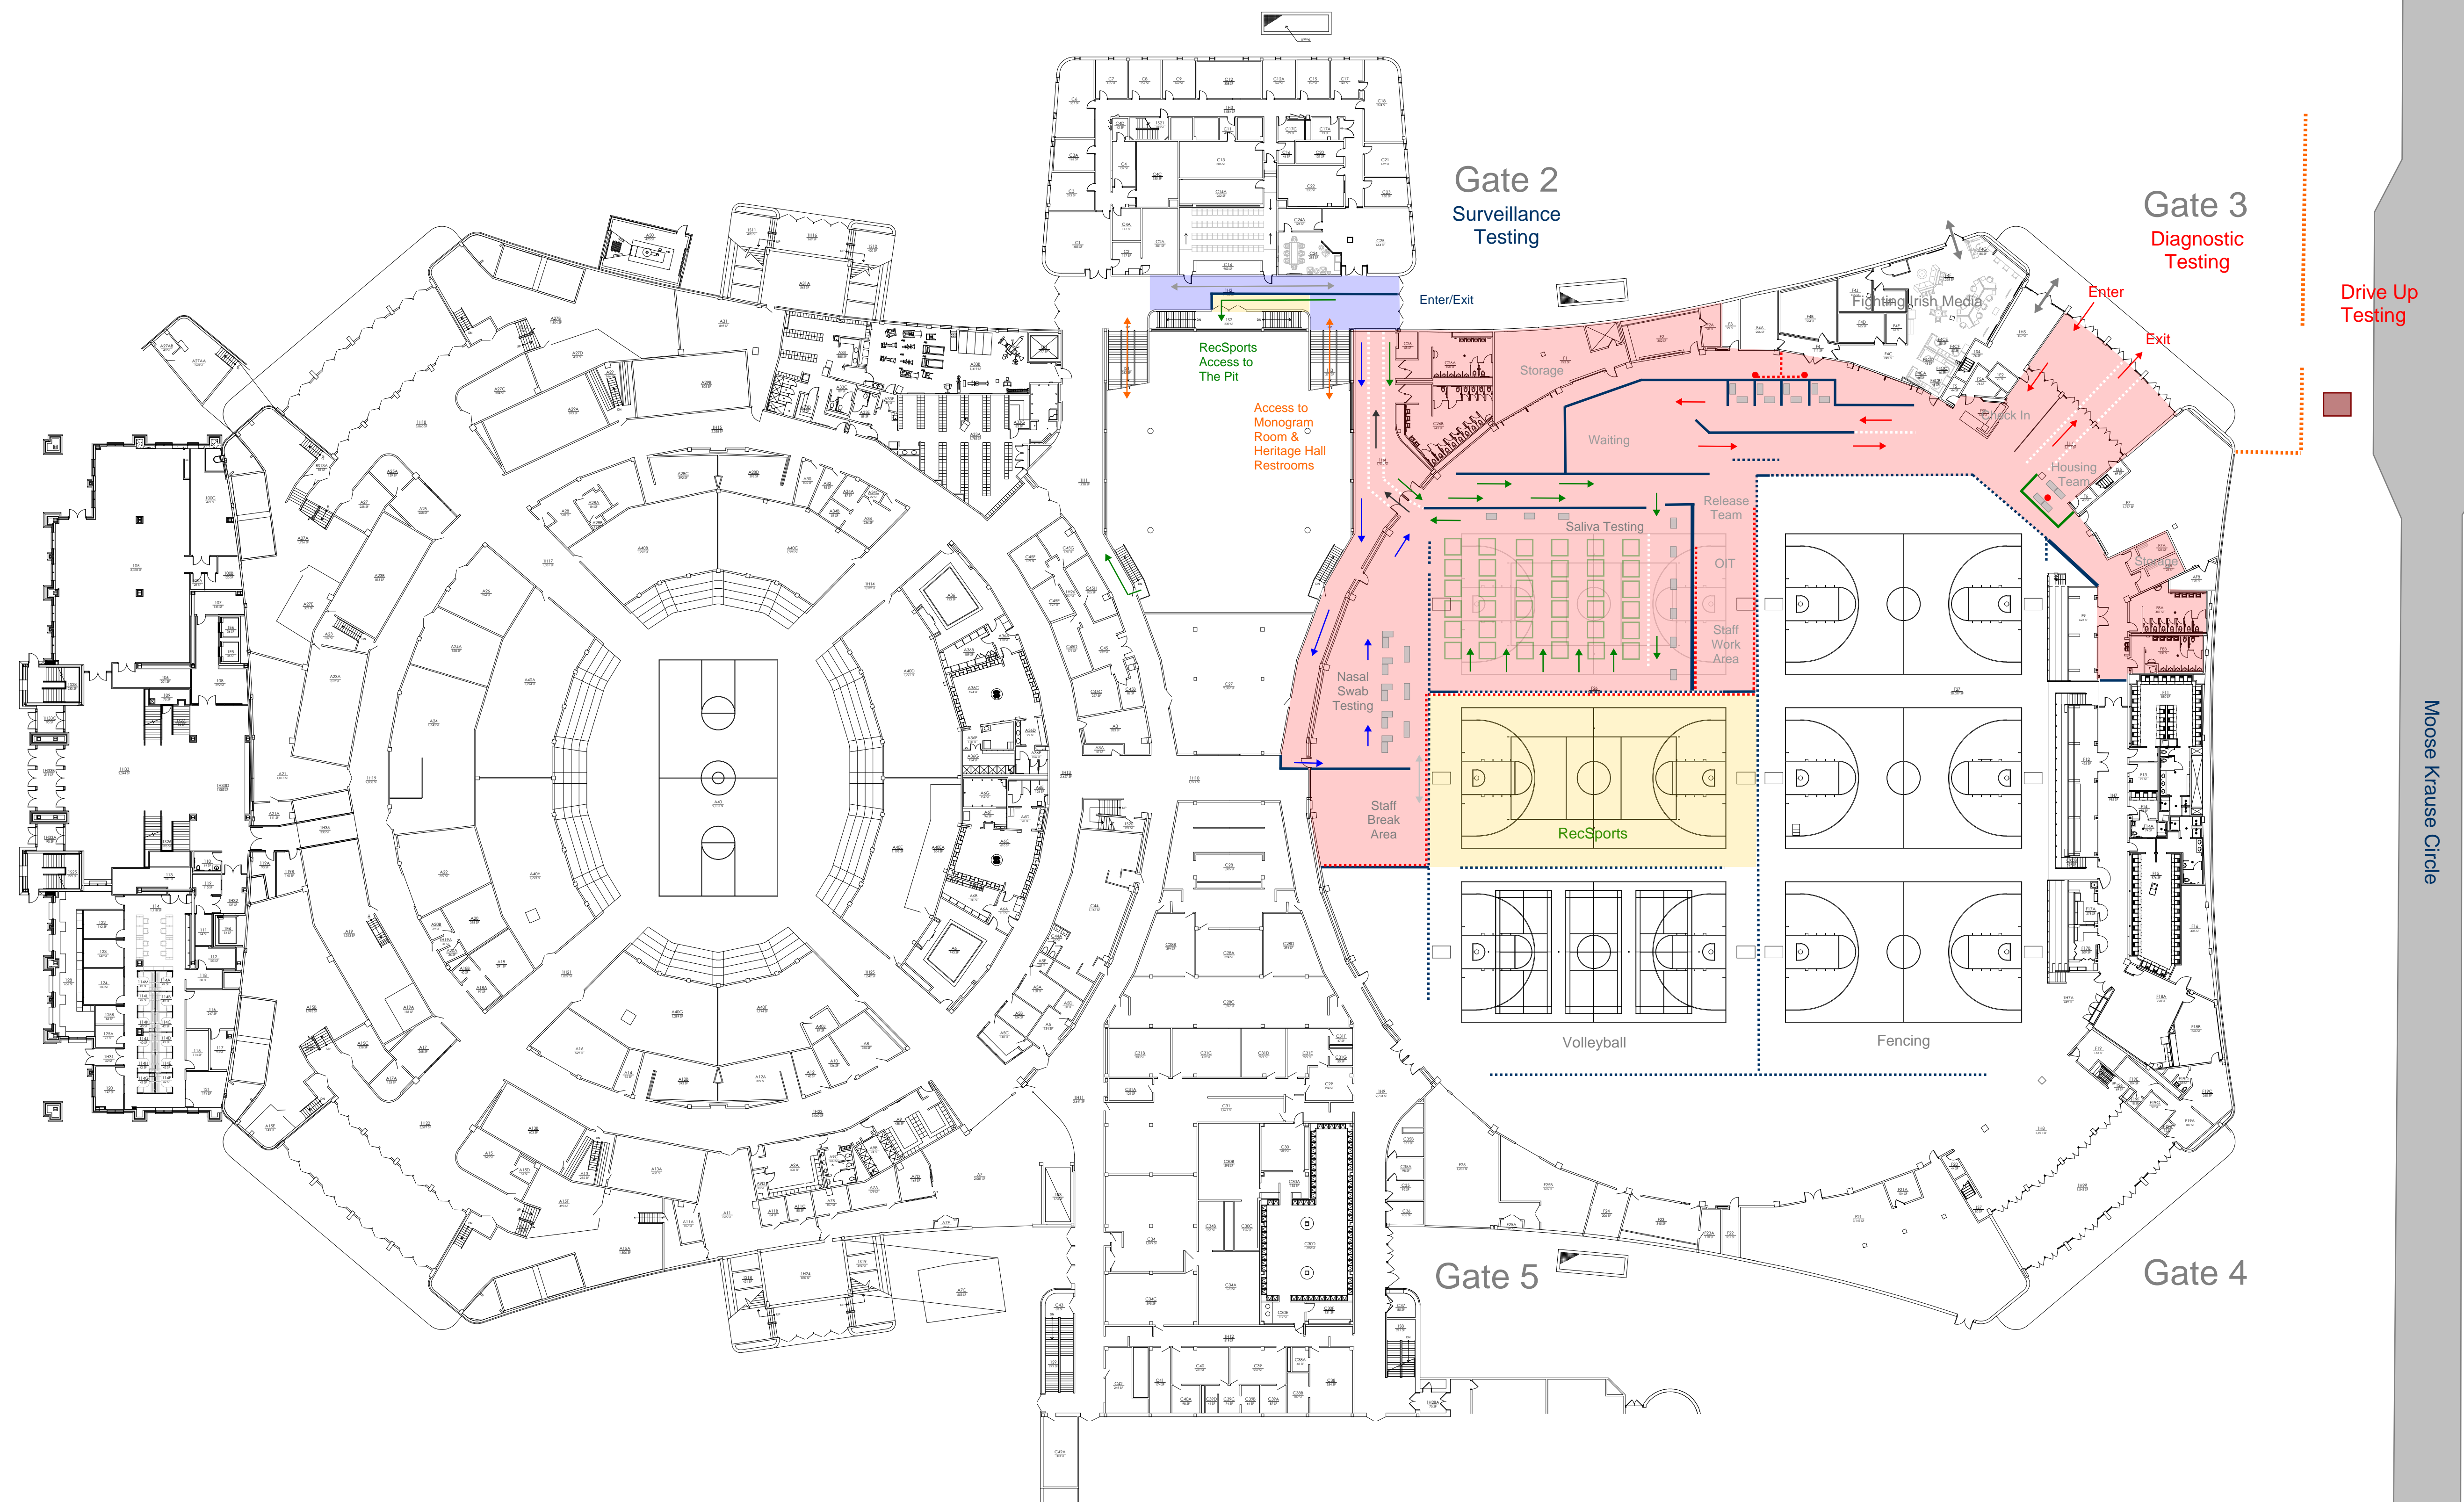

Moose Krause Circle

D	ADDED ROOM C34C & A24A - MDS	3/7/17	H	RENOVATIONS AT SECTION "C"	3/9/20
C	RENOVATED ROOM A7D - MDS	1/26/16	G	Renovations at F7, new locker rooms, new court striping	3/7/19
B	RENOVATED HOCKEY ARENA INTO FENCING - MDS	4/18/13	F	Renovated Rooms A18, A18A & A18B. Deleted 1H19B - MDS	3/20/18
A	ADDED DIGITAL MEDIA - MDS	4/16/13	E	ADDED FURNITURE TO RM 114 - MDS	3/16/17
REV	DESCRIPTION	DATE	REV	DESCRIPTION	DATE



UNIVERSITY OF NOTRE DAME
Facilities Design & Operations

100 FACILITIES BUILDING
NOTRE DAME, IN 46556

(574) 631-6594
FAX: (574) 631-8468

BASE FLOOR PLAN JOYCE CENTER		DRAWN BY: WN/DM	DATE: 5/16/66	SCALE: 1/32" = 1' 0"
FIRST FLOOR		APPROVED:	DATE:	PROJECT PHASE:
PRINT DATE:		---		
DWG. NAME	108301	REV.		