



Indiana Department of Environmental Management
Office of Water Quality
Waterways Section

Publication Date:
June 11, 2026

IDEM Permit Number:
WQC001488

PUBLIC NOTICE

Closing Date:
July 02, 2026

Corps of Engineers ID Number:

To all interested parties:

This letter shall serve as a formal notice of the receipt of an application for Section 401 Water Quality Certification by the Indiana Department of Environmental Management (IDEM). The purpose of the notice is to inform the public of active applications submitted for water quality certification under Section 401 of the Clean Water Act (33 U.S.C. § 1341) and to solicit comments and information on any impacts to water quality related to the proposed project. IDEM will evaluate whether the project complies with Indiana's water quality standards as set forth at 327 IAC 2.

1. Applicant: Kevin Krulik
City of Lebanon
401 South Meridian
Lebanon, IN, 46052

2. Agent: Randy Jones
AquaTerra Consulting Inc
151 North Home Avenue
Franklin, IN, 46131

3. Project Location: Lebanon, IN, 46052
Latitude: 40.0746
Longitude: -86.4581

4. Affected Waterbody: UNT to Prairie Creek

5. Project Description: Approximately 911 linear feet (lf) of an existing residential drainage ditch (UNT to Prairie Creek) will be relocated to an adjacent property north of the current alignment. The relocated stream will be expanded to 928 lf and designed as a two-stage, meandering ditch before entering Prairie Creek. This expanded relocation will serve as mitigation for impacts to the original ditch.

Of the 911 lf existing channel, 600 lf will be enclosed in storm sewer, and the remaining 311 lf will be filled and regraded to existing contours.

For additional information visit the Regulatory ePortal at: <https://waterquality.idem.in.gov>

Comment Period: Any person or entity who wishes to submit comments or information relevant to the aforementioned project may do so by the closing date noted above. Only comments or information related to water quality or potential impacts of the project on water quality can be considered by IDEM in the water quality certification review process.

Public Hearing: Any person may submit a written request that a public hearing be held to consider issues related to water quality in connection with the project detailed in this notice. The request for a hearing should be submitted within the comment period to be considered timely. The request should also state the reason for the public hearing as specifically as possible to assist IDEM in determining whether a public hearing is warranted.

Questions? Submit requests for additional information and written comments to WaterwaysComments@idem.IN.gov. In the subject line of the email, please include the IDEM ID Number listed in the top right corner of the first page of this public notice. Indicate if you wish to receive a copy of IDEM's final decision. Comments and inquiries may also be forwarded to -

Office of Water Quality
Indiana Department of Environmental Management
100 North Senate Avenue, IGCN 1255
Indianapolis, Indiana 46204-2251

CHADWICK VILLAGE CITY DITCH RECONSTRUCTION


SECTION 19, TOWNSHIP 19N, RANGE 1E

CENTER TOWNSHIP



BOONE COUNTY

PLANS PREPARED FOR:

CITY OF LEBANON
401 SOUTH MERIDIAN STREET
LEBANON, IN 46052
PHONE: (765) 482-8845
CONTACT: KEVIN KRULIK

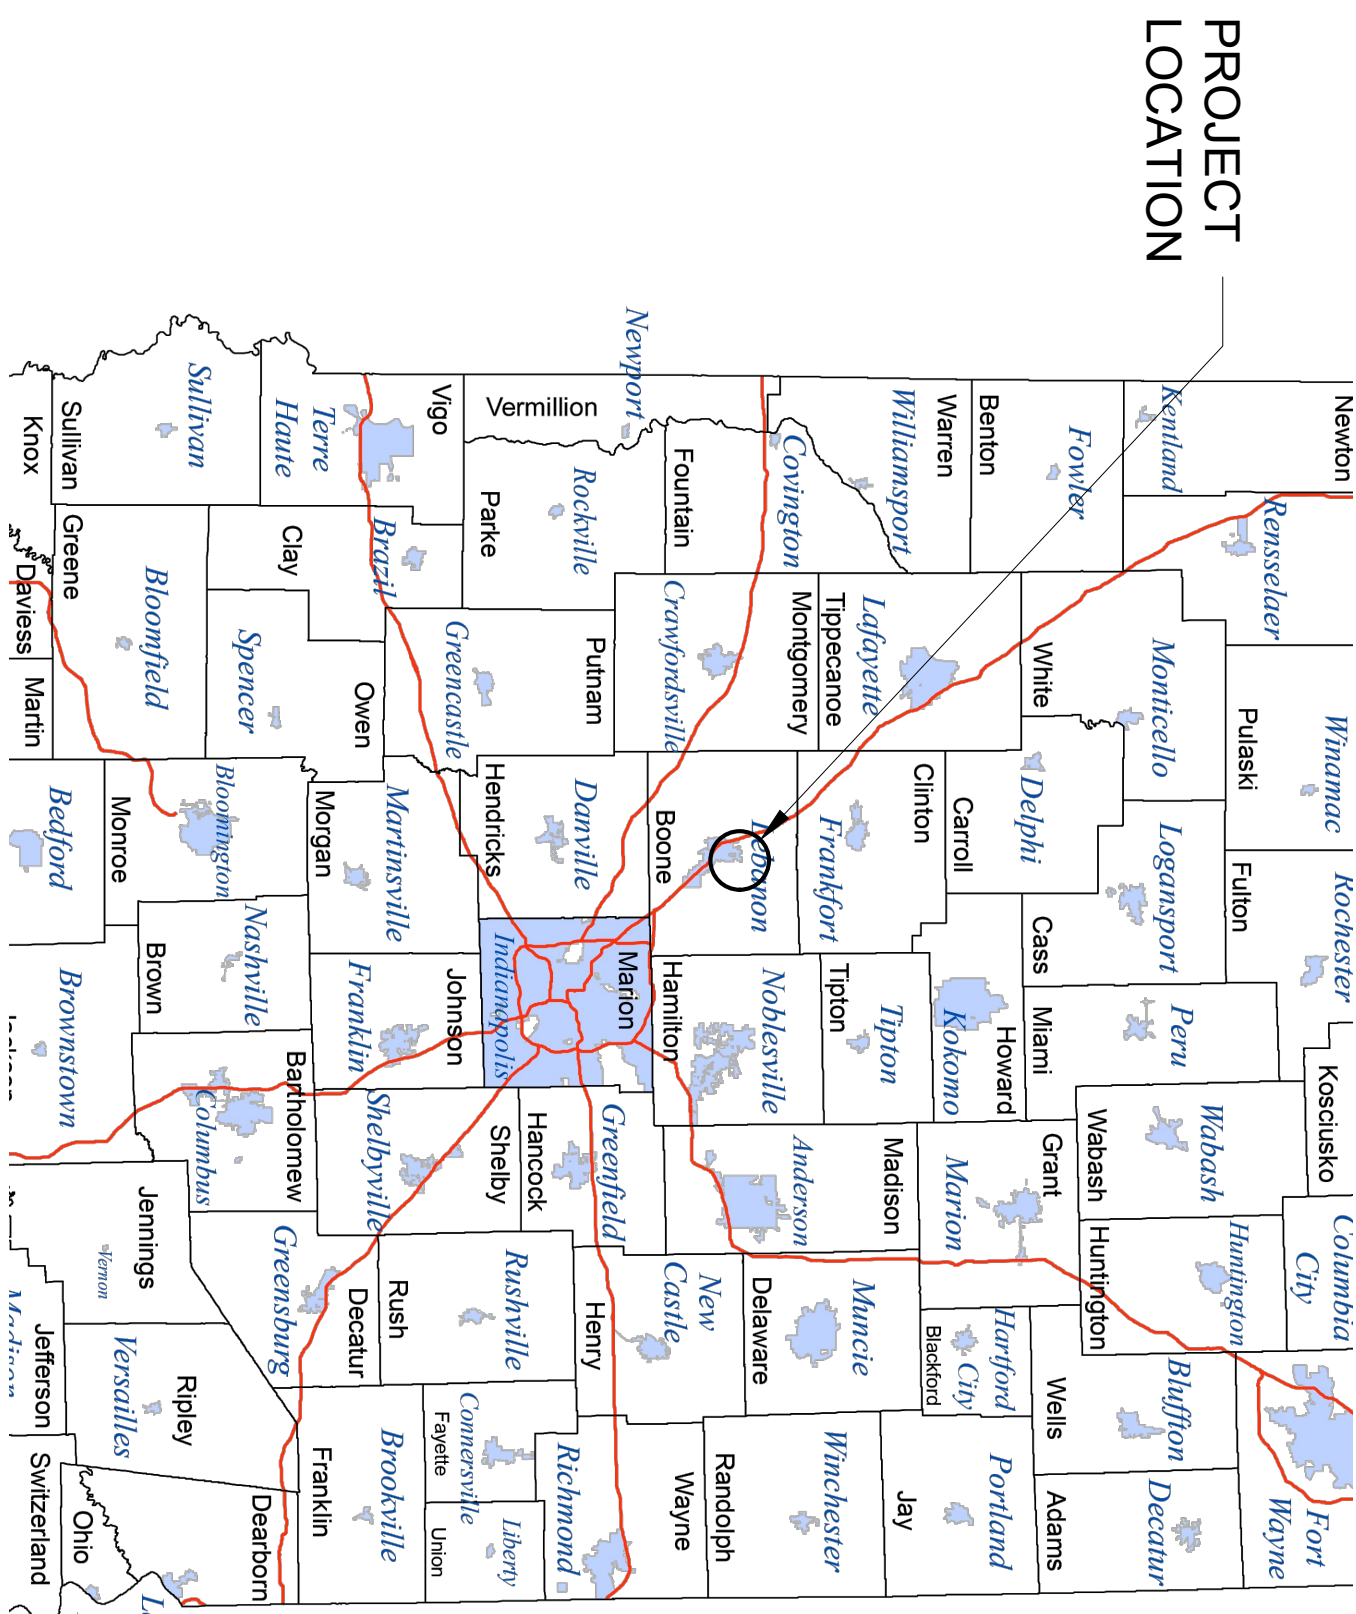


OPERATING AUTHORITIES		
GAS	COMMUNICATION	WATER
Centerpoint Energy 1800 W. 28th St. Muncie, IN 47302 765-287-2719	AT&T 2400 N. Meridian St., Room 1791 Indianapolis, IN 46204 317-220-7043 Jon Eastham	Lebanon Utilities 401 S. Meridian St. Lebanon, IN 46052 765-482-8367
	ELECTRIC Lebanon Utilities 401 S. Meridian St. Lebanon, IN 46052 765-482-8367	SEWER Lebanon Utilities 401 S. Meridian St. Lebanon, IN 46052 765-482-8367
	FIBER OPTIC Lebanon Utilities 401 S. Meridian St. Lebanon, IN 46052 765-482-8367	CABLE TV Comcast Cable (Indianapolis) 5330 E. 65th St. Indianapolis, IN 46220 (317) 450-2612
		COMMUNICATION Windstream 4005 N. Rodney Parham Rd. Little Rock, AR 72212 800-289-1901
		SCHOOL DISTRICT Lebanon Community School Corp. 1810 N. 5th St. Lebanon, IN 46052 765-482-0380
		FIRE DEPARTMENT Lebanon Fire Station 12 16 Anderson Ln. Lebanon, IN 46052 765-482-9827

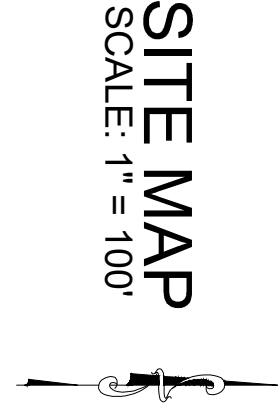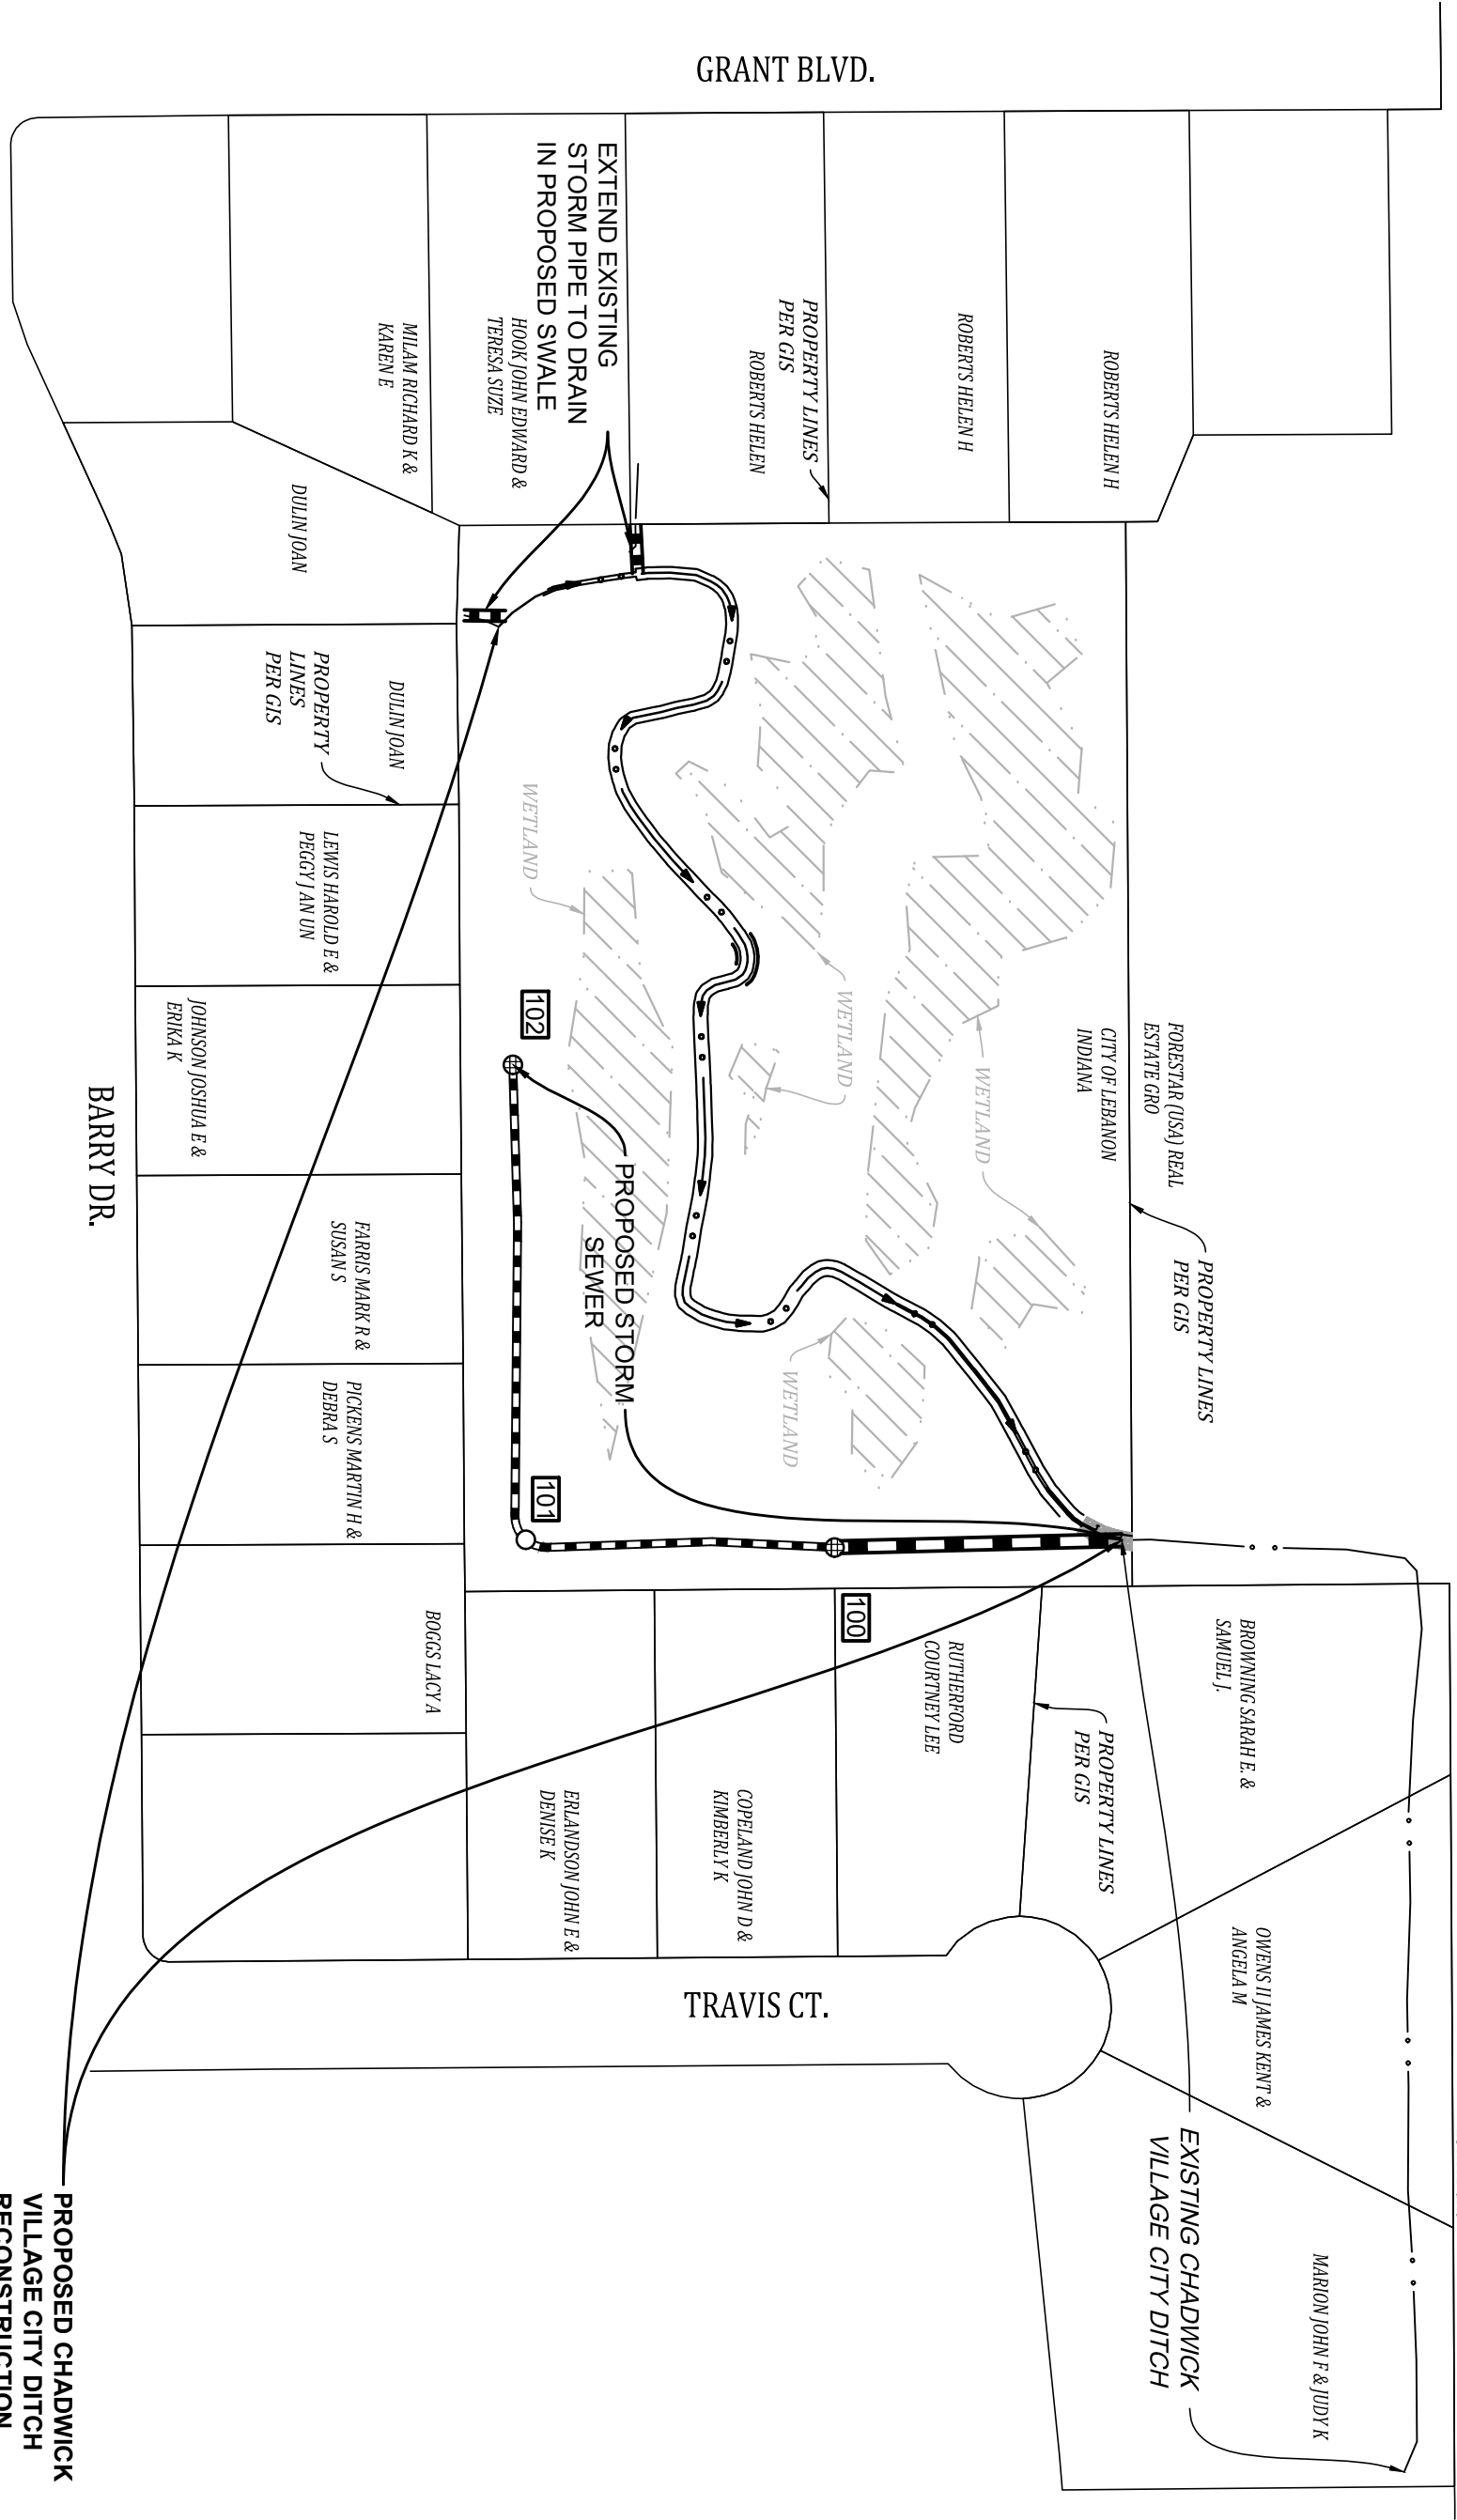

REVISIONS	
NUMBER	DESCRIPTION

SHEET INDEX	
SHEET NO	DESCRIPTION
C100	TITLE SHEET
C101	OVERALL PLAN
C102	EXISTING TOPOGRAPHY AND DEMO PLAN
C110	GRADING AND DRAINAGE PLAN
C300	STORM SEWER PLAN AND PROFILE
C400	INITIAL EROSION CONTROL PLAN
C401	FINAL EROSION CONTROL PLAN
C402	STORM WATER POLLUTION PREVENTION PLAN
C500	MISCELLANEOUS DETAILS
1-25	CITY OF LEBANON STANDARDS

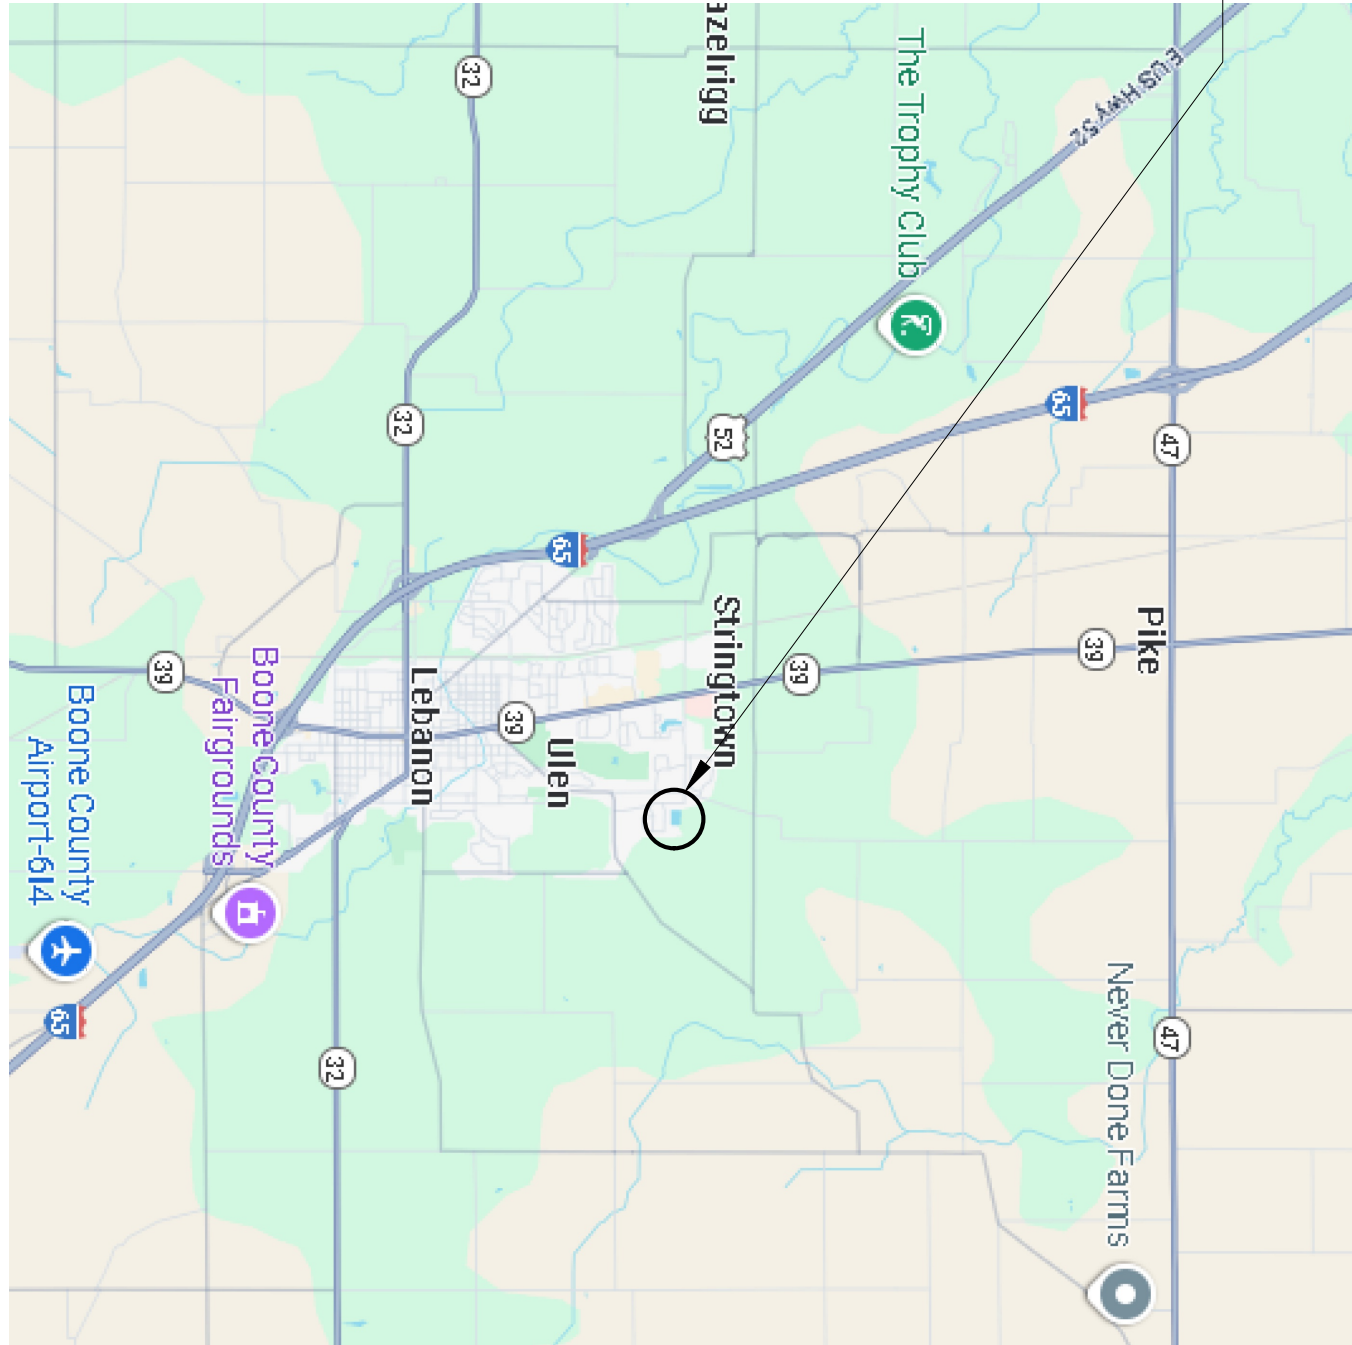

PLANS PREPARED BY:
BANNING ENGINEERING
853 COLUMBIA ROAD, SUITE #101
PLAINFIELD, IN 46168
BUS.: (317) 707-3700, FAX: (317) 707-3800
E-MAIL: Banning@BanningEngineering.com
WEB: www.BanningEngineering.com
CONTACT: JOE MILLER
EMAIL: jmiller@banning-eng.com

CONSTRUCTION DOCUMENTS
PROJECT MANAGER: _____ DATE: _____
THESE PLANS ARE NOT TO BE CONSIDERED FINAL OR TO BE UTILIZED FOR CONSTRUCTION UNLESS SIGNED AND DATED BY THE APPROPRIATE BANNING ENGINEERING PROJECT MANAGER.
THESE PLANS ARE NOT INTENDED TO BE REPRESENTED AS A RETRACTION OR ORIGINAL BOUNDARY SURVEY, A ROUTE SURVEY OR A SURVEYOR LOCATION REPORT.

CERTIFIED BY: _____

