



CONTENTS
GROUND FLOOR
PLAN -
ARENA

DATE 10.02.80
APPROVED JK
CHECKED JK
DRAWN JK

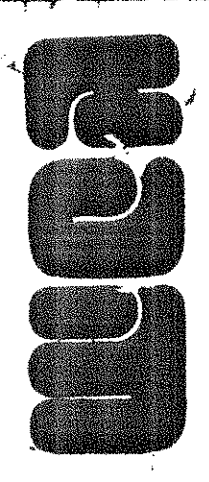


WALLACE, MITCHELL & DRUCKER
CONSULTING
MECHANICAL
ELECTRICAL
ENGINEERS
444 N. PULASKI
CHICAGO, ILL. 60610
180 N. MICHIGAN
CHICAGO, ILL. 60610
ARCHITECTS
3008 E. 140TH STREET
CHICAGO, ILL. 60640
WALLACE, MITCHELL & DRUCKER
CONSULTING
MECHANICAL
ELECTRICAL
ENGINEERS
444 N. PULASKI
CHICAGO, ILL. 60610

GENESIS CENTER
ADAMS, BROADWAY, AND FIFTH AVENUE
CITY OF GARY,
INDIANA
RICHARD G. HATCHER,
MAYOR

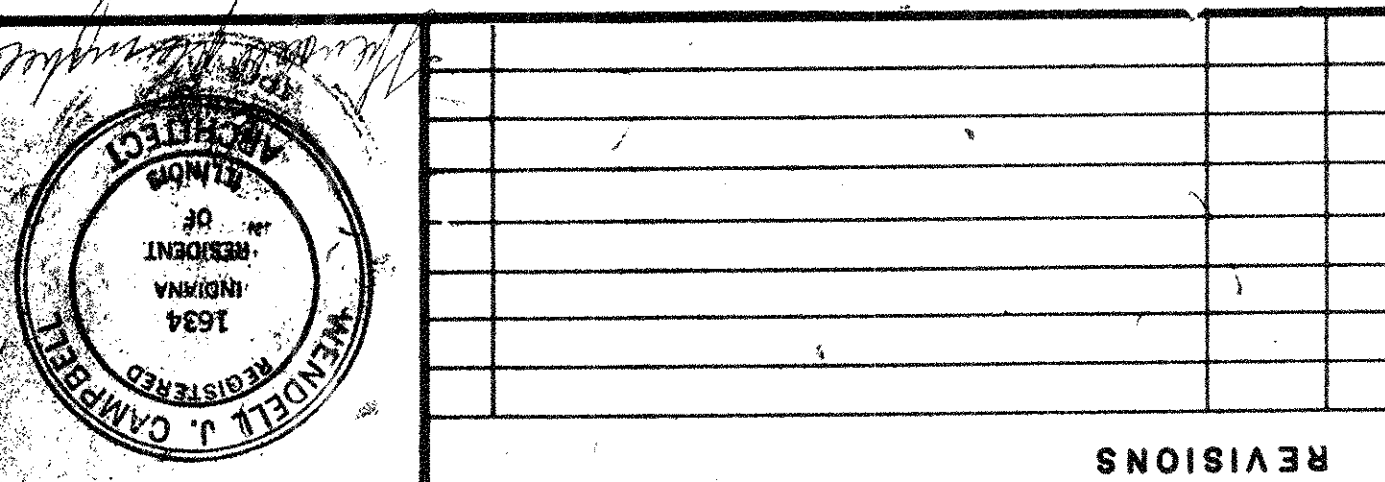

REVISIONS

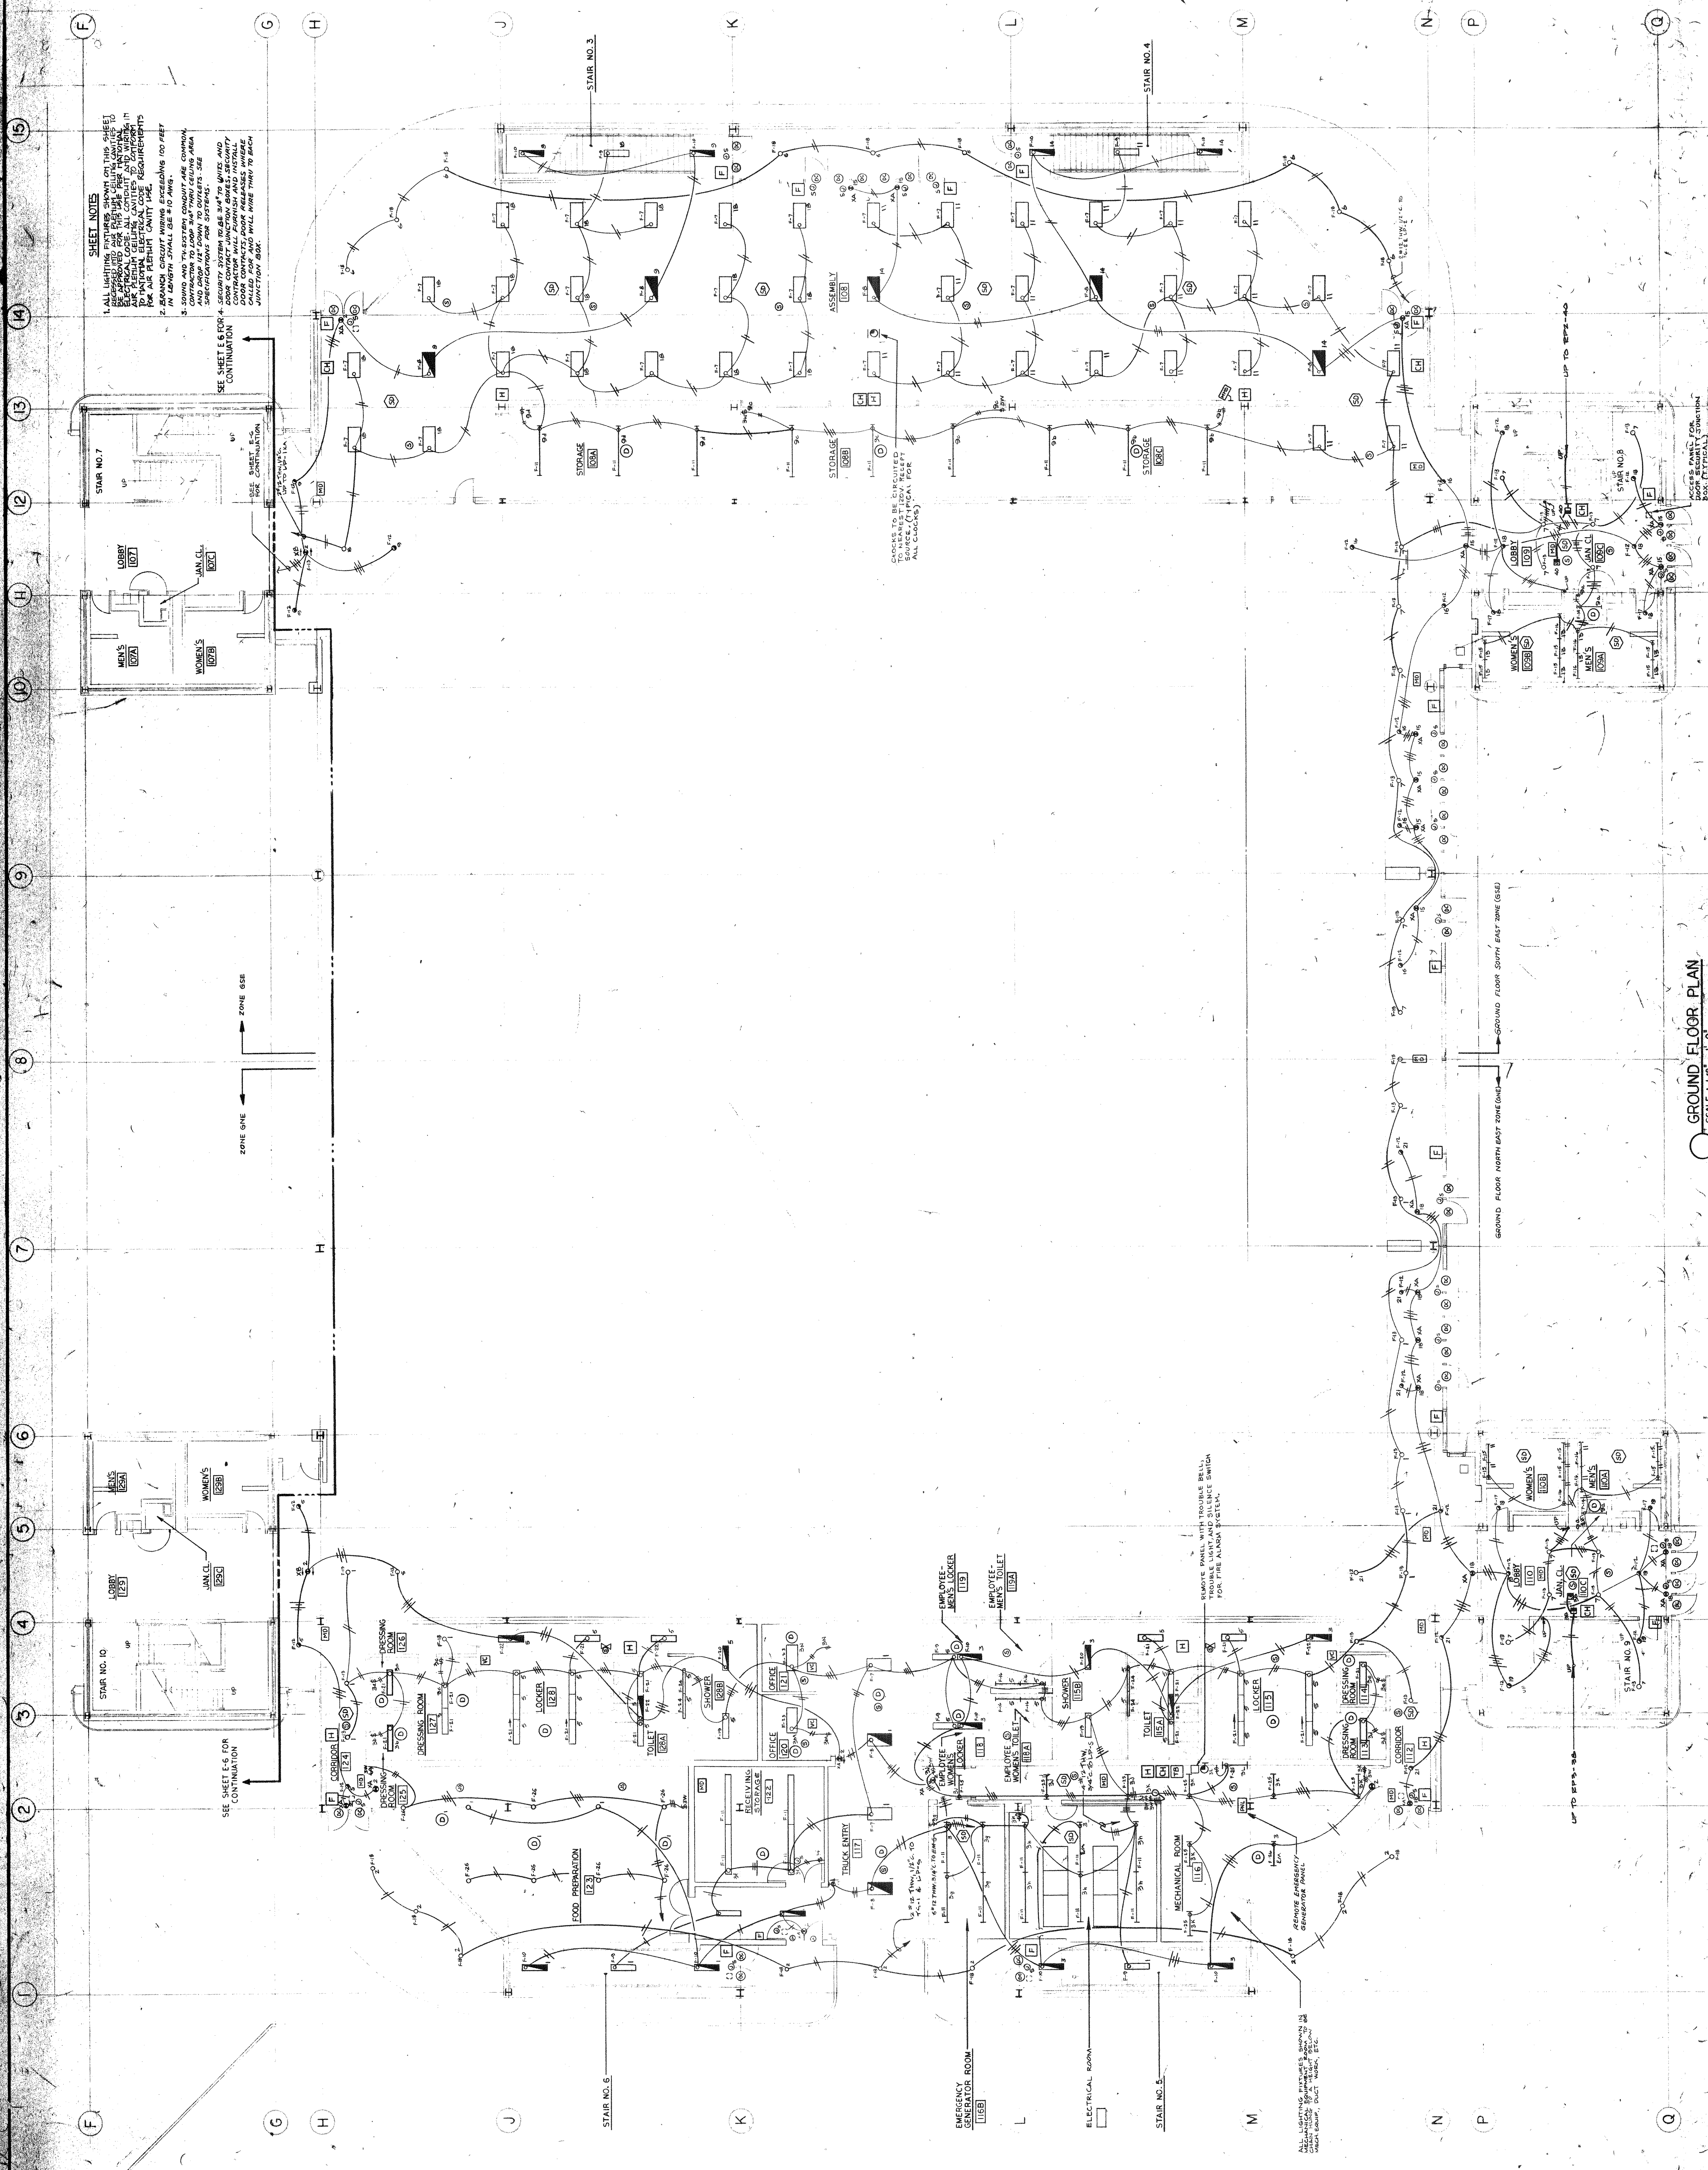

GROUND FLOOR PLAN
SCALE: 1/8" = 1'-0"