

CONTENTS
GROUND FLOOR
PLAN
ARENA BLDG.


DATE 07-02-80
APPROVED
CHECKED
DRAWN

WALLACE, MODAL & DRUCKER
CONSULTING
ELECTRICAL
ENGINEERS
444 N. MICHIGAN AVENUE
SUITE 1000 CHICAGO, ILL. 60610


WALLACE, MODAL & DRUCKER
ARCHITECTS
180 N. MICHIGAN AVENUE
SUITE 1000 CHICAGO, ILL. 60610
RICHARD & HATCHER,
CITY OF GARY,
ADAMS, BROADWAY, AND FIFTH AVENUE
MAYOR

GENESIS CENTER
CITY OF GARY,
ADAMS, BROADWAY, AND FIFTH AVENUE
MAYOR

R.F. STIONS

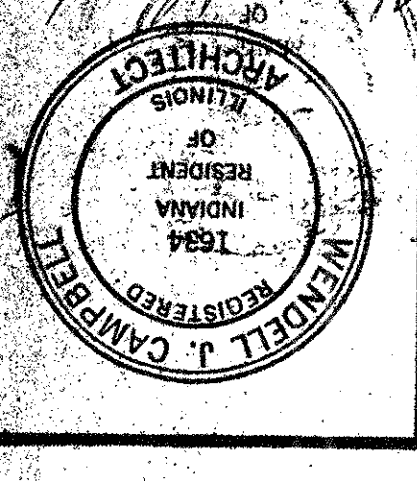

① GROUND FLOOR PLAN
SCALE: 1/8" = 1'-0"

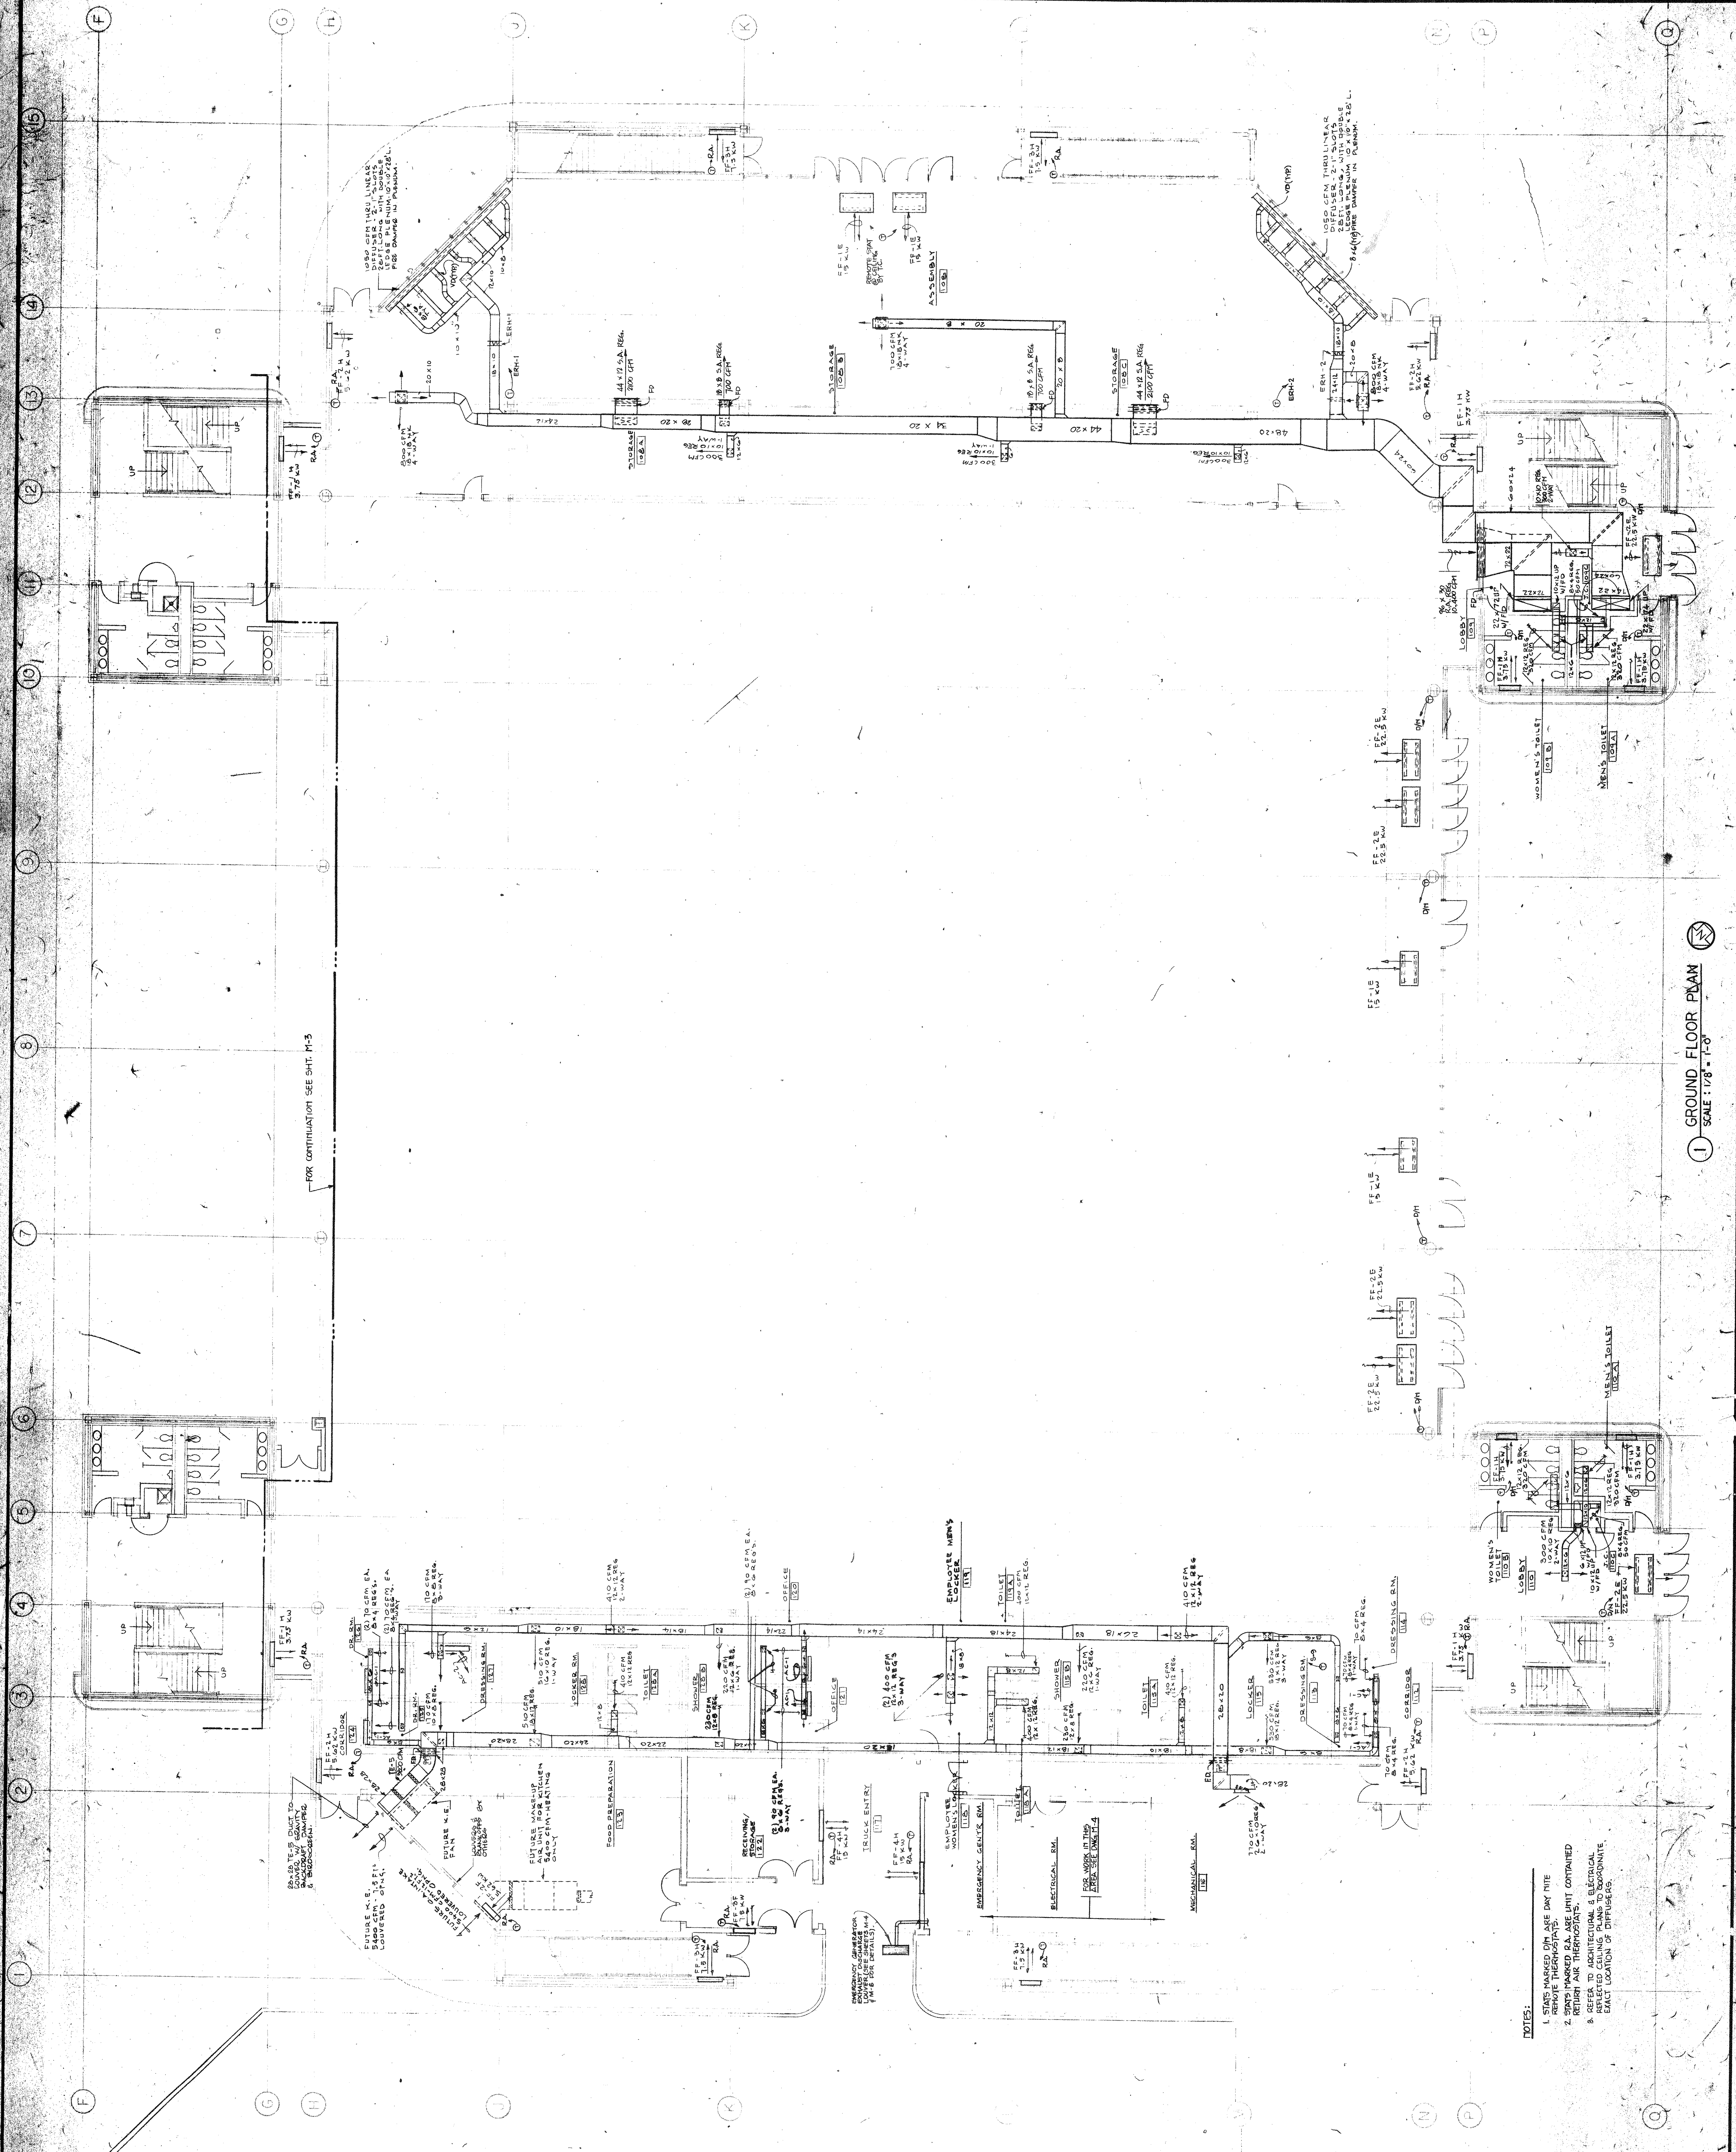

- NOTES:
1. STAIRS MARKED WITH DAY NITE
 2. REPAIRS TO EXISTING UNIT OBTAINED
 3. REPAIRS TO EXISTING UNIT OBTAINED
 4. REPAIRS TO EXISTING UNIT OBTAINED
 5. REPAIRS TO EXISTING UNIT OBTAINED
 6. REPAIRS TO EXISTING UNIT OBTAINED
 7. REPAIRS TO EXISTING UNIT OBTAINED
 8. REPAIRS TO EXISTING UNIT OBTAINED
 9. REPAIRS TO EXISTING UNIT OBTAINED
 10. REPAIRS TO EXISTING UNIT OBTAINED
 11. REPAIRS TO EXISTING UNIT OBTAINED
 12. REPAIRS TO EXISTING UNIT OBTAINED
 13. REPAIRS TO EXISTING UNIT OBTAINED
 14. REPAIRS TO EXISTING UNIT OBTAINED
 15. REPAIRS TO EXISTING UNIT OBTAINED