

REVISIONS

GENESIS CENTER
ADAMS, BROADWAY, AND FIFTH AVENUE
CITY OF GARY, INDIANA
RICHARD G. HATCHER, MAYOR


WALLACE, MEGDAL & PRUCKER
CONSULTING ELECTRICAL ENGINEERS
1800 N. MICHIGAN AVENUE, CHICAGO, ILL. 60610
444 N. OGDEN, CHICAGO, ILL. 60610

WALLACE, MEGDAL & PRUCKER
CONSULTING ELECTRICAL ENGINEERS
1800 N. MICHIGAN AVENUE, CHICAGO, ILL. 60610
444 N. OGDEN, CHICAGO, ILL. 60610

DATE: 01-28-80
APPROVED: [Signature]
DRAWN: N.M.
CHECKED: C.C.


CONTENTS
GROUND FLOOR &
SECOND FLOOR
PLAN
EXHIBIT HALL
BUILDING

M-3

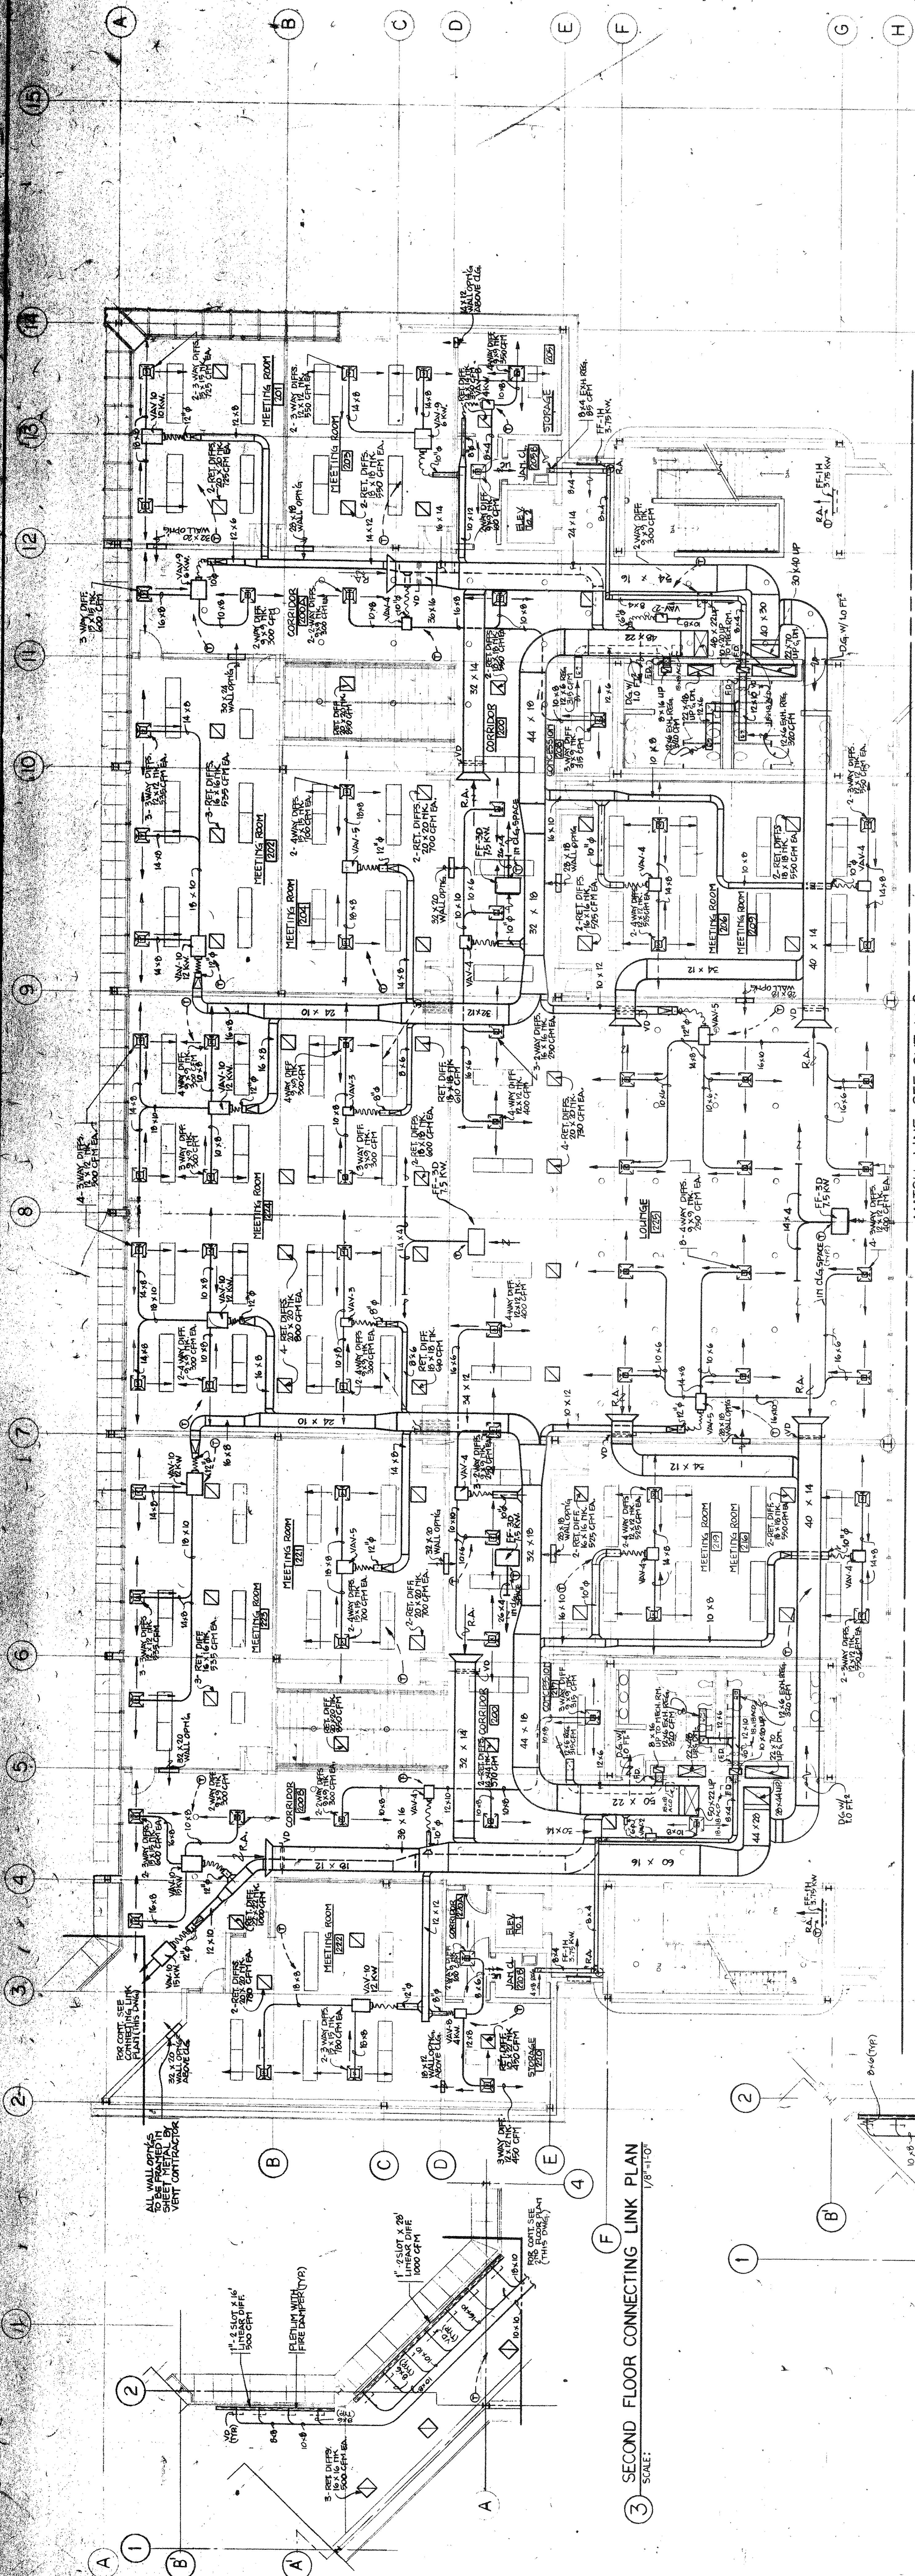

③ SECOND FLOOR CONNECTING LINK PLAN
SCALE: 1/8"=1'-0"

MATCH LINE SEE SHT. M-2

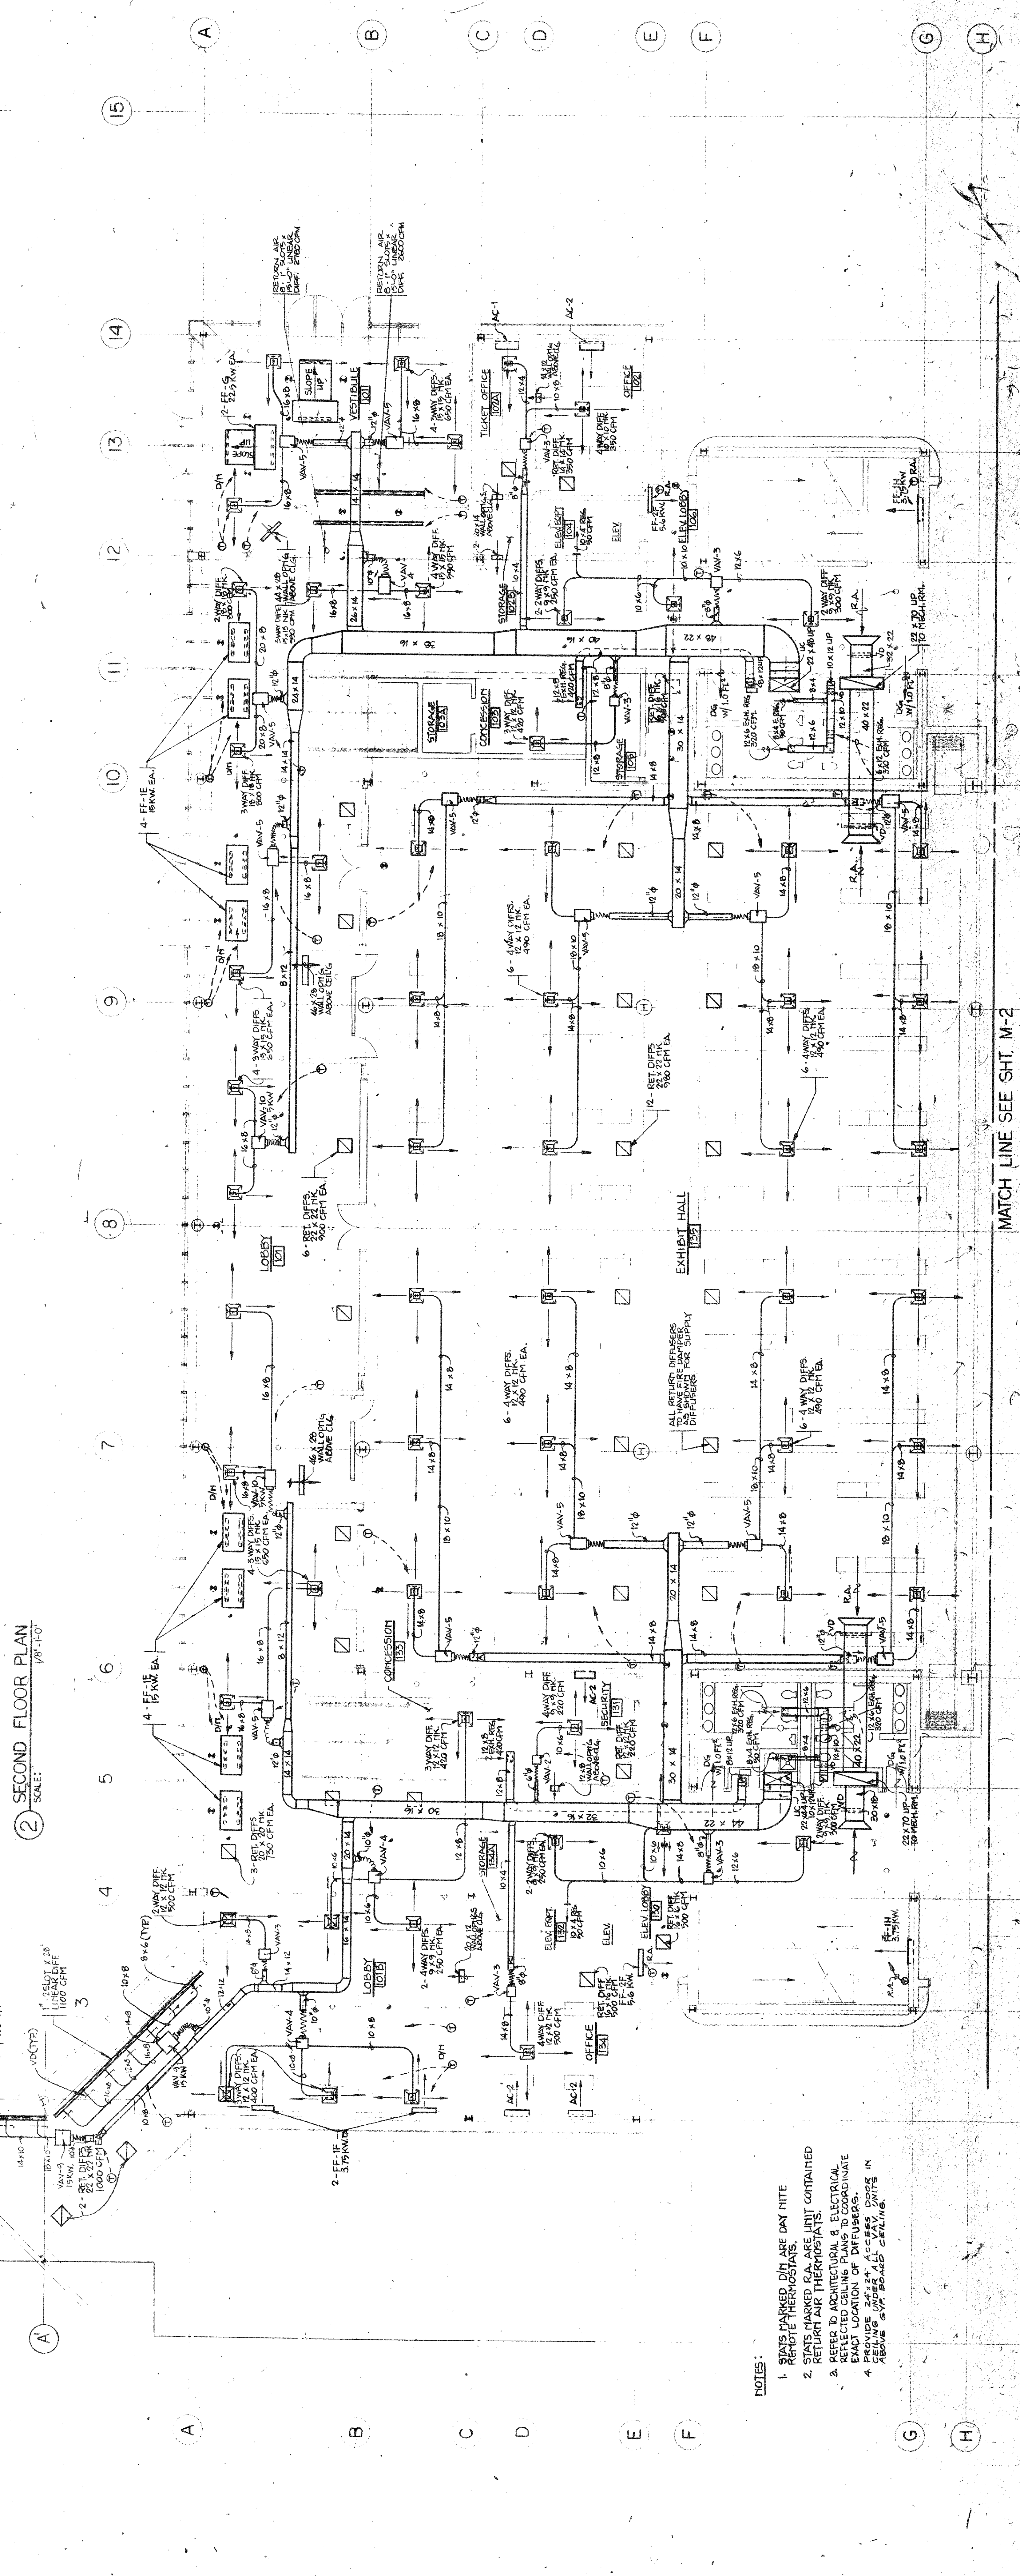

② SECOND FLOOR PLAN
SCALE: 1/8"=1'-0"

MATCH LINE SEE SHT. M-2

- NOTES:
1. STAIRS MARKED DIN ARE DAY NITE
 2. STAIRS MARKED RA ARE RAMP CONTAINED
 3. RETURN AIR THERMOSTATS
 4. EXACT LOCATION OF DIFFUSERS
 5. EXACT LOCATION OF DIFFUSERS
 6. EXACT LOCATION OF DIFFUSERS
 7. EXACT LOCATION OF DIFFUSERS
 8. EXACT LOCATION OF DIFFUSERS
 9. EXACT LOCATION OF DIFFUSERS
 10. EXACT LOCATION OF DIFFUSERS
 11. EXACT LOCATION OF DIFFUSERS
 12. EXACT LOCATION OF DIFFUSERS
 13. EXACT LOCATION OF DIFFUSERS
 14. EXACT LOCATION OF DIFFUSERS
 15. EXACT LOCATION OF DIFFUSERS

① GROUND FLOOR PLAN
SCALE: 1/8"=1'-0"